


# DIMENSIONS OF PROPOSED EXCAVATIONS

MATERIAL	DIMENSION(S)	PROPOSED SUBSURFACE DEPTH
STEEL PICKET FENCE (NEW) CONCRETE FOOTINGS	16" W/ 6' O.C.	48"
4' HEIGHT CHAIN LINK FENCE CONCRETE FOOTINGS	12" W/ 6' O.C.	48"
GRANITE BOLLARD CONCRETE FOOTINGS	24" W/ 6' O.C.	48"
STONE SLAB AT NORTHEAST ENTRANCE (GRAVEL BASE)	SIZE OF SLAB	6" BELOW SLAB
STABILIZED STONE DUST PATHWAY	4' W	11"
TREE PITS	5' MAX.	36" MAX.
RECYCLED GRANITE BENCHES (GRAVEL BASE)	6' L x 30" W +/-	6"
ELECTRICAL CONDUIT*	6" W TRENCH	18" AND 24"
HANDHOLD FOR ELECTRICAL*	11" X 18"	18"
IN-GROUND ELECTRICAL FIXTURES	TO BE DETERMINED	12" +/-

\* FOR LOCATIONS OF PROPOSED CONDUIT AND HANDHOLDS, REFER TO SHEET SE-1 (ELECTRICAL SITE PLAN)


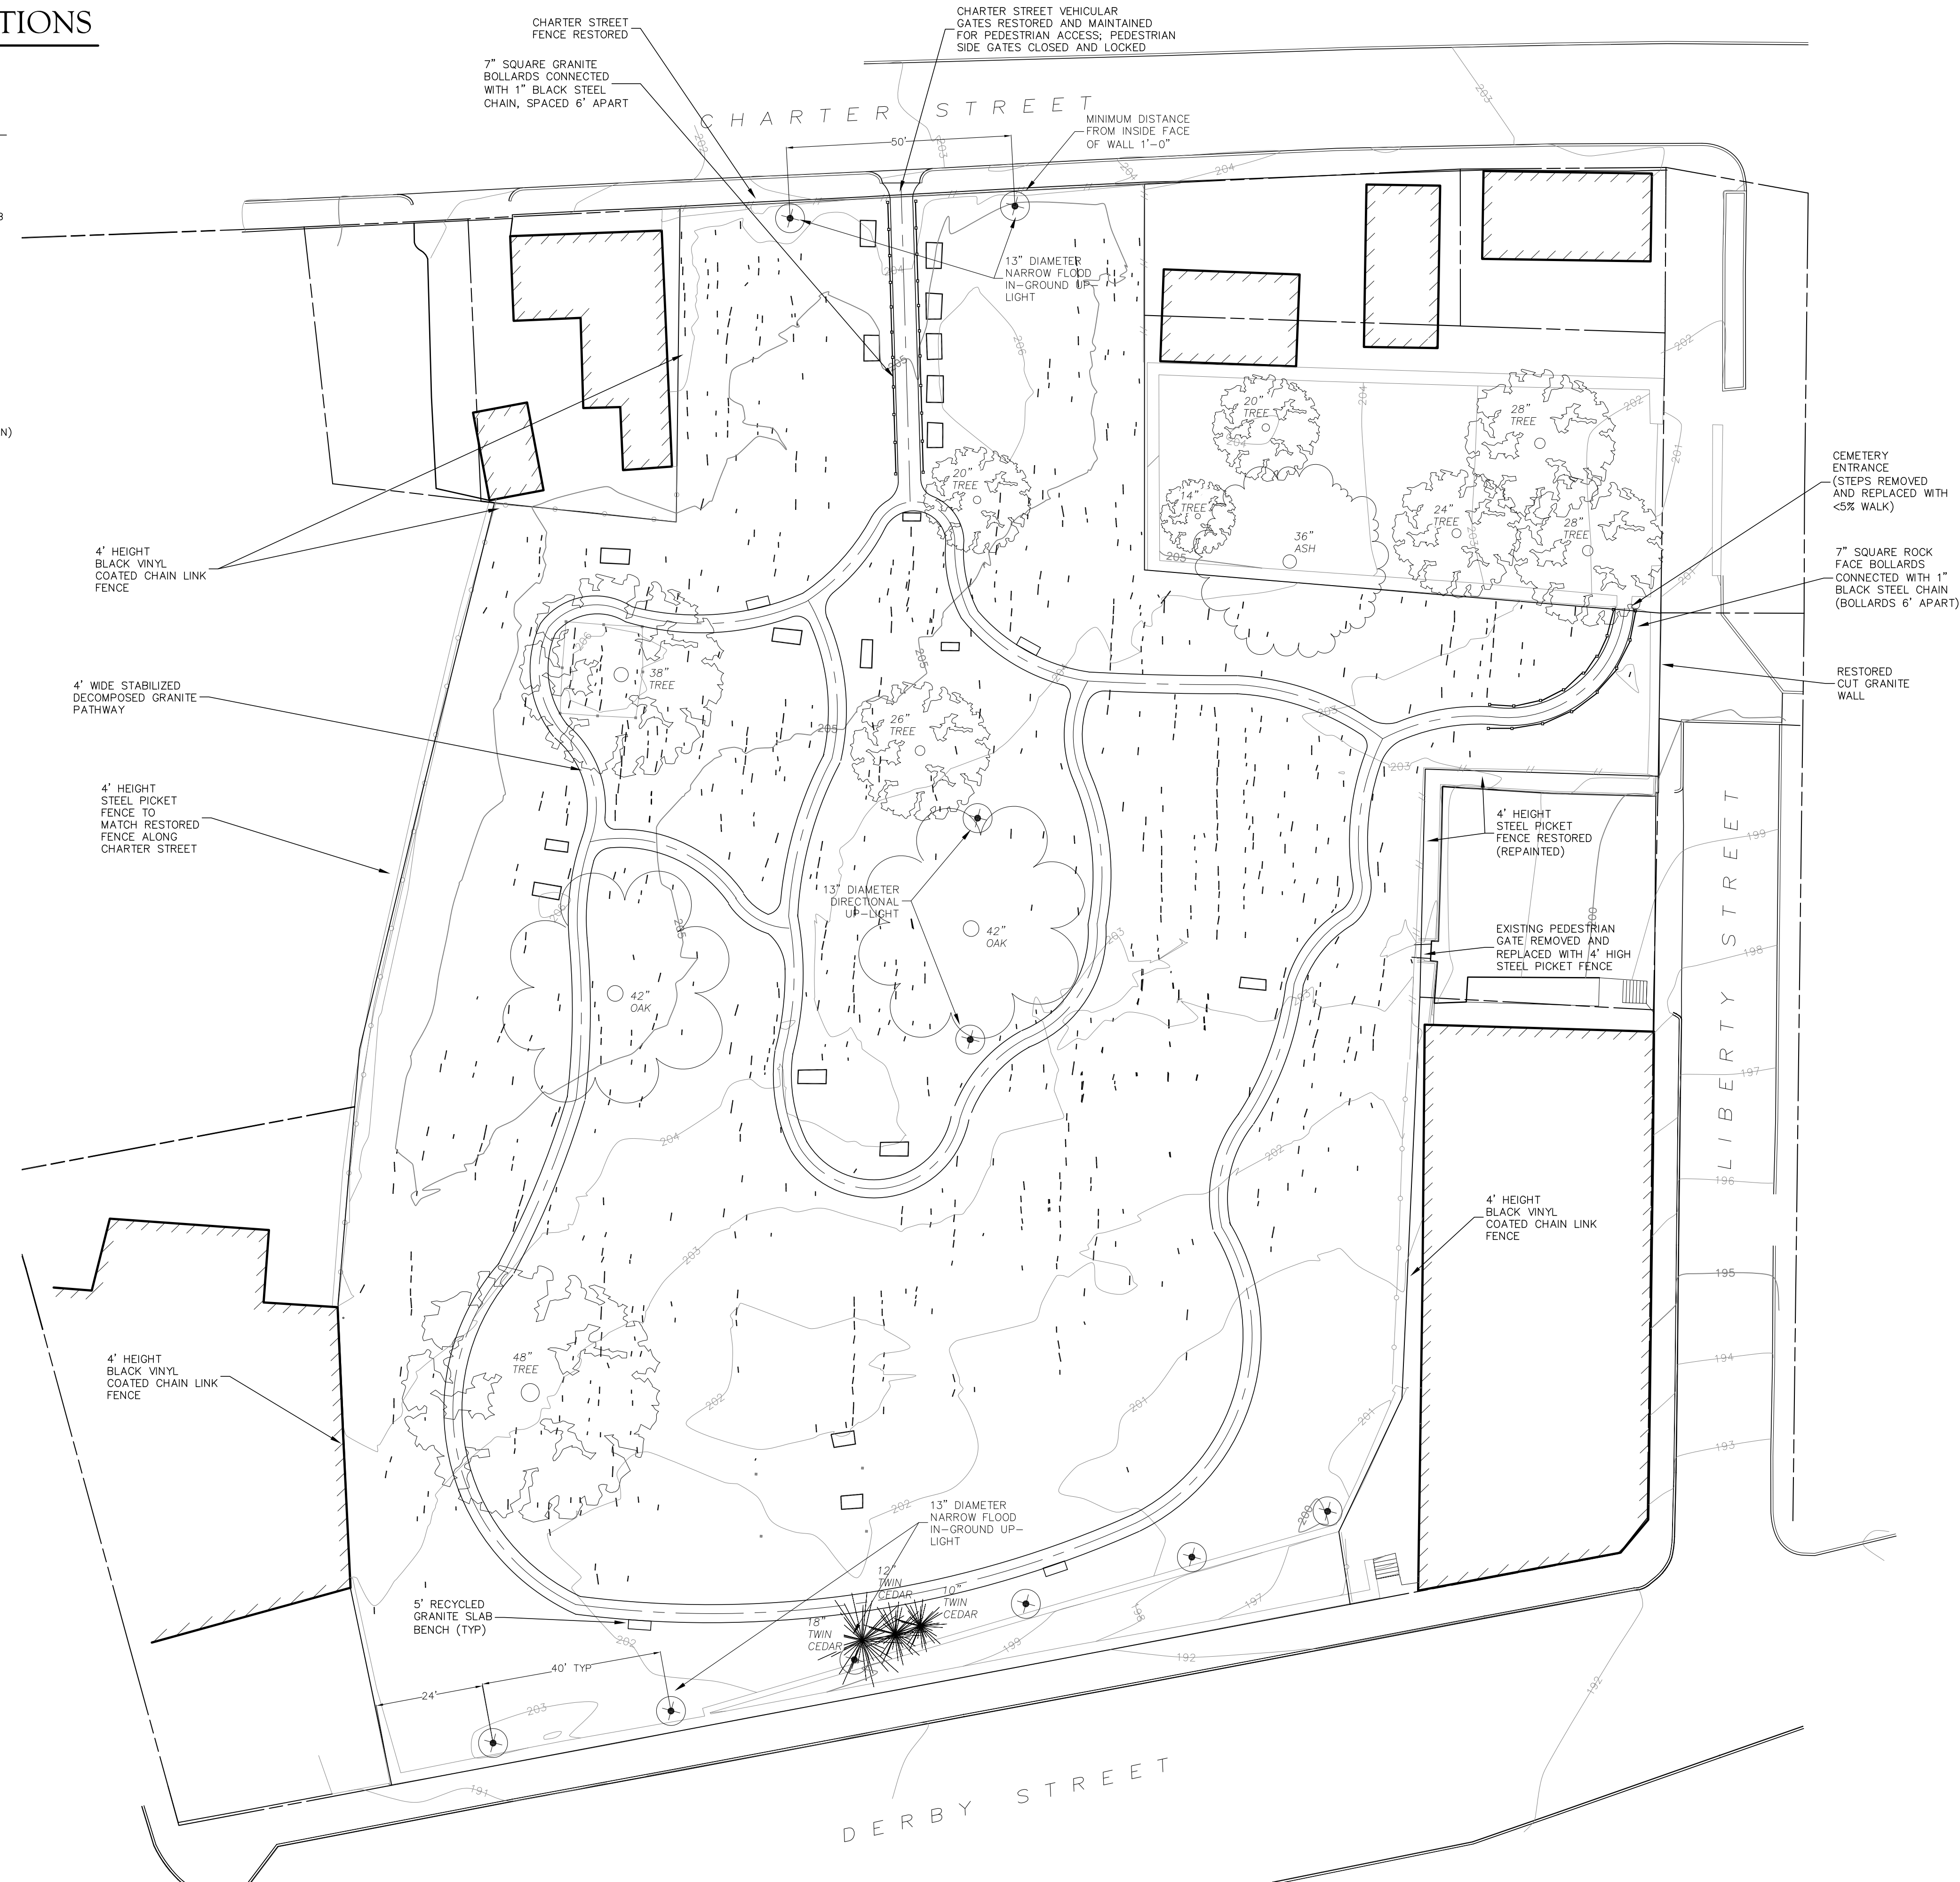


## CHARTER STREET CEMETERY PRESERVATION PROJECT

120 Washington Street, 3rd Floor  
Salem, Massachusetts  
01970

### MARTHA LYON Landscape Architecture, LLC

313 Elm Street  
Northampton, MA 01060  
p: 413-586-4178  
f: 413-584-6697  
e: mhl@marthalyon.com  
www.marthalyon.com

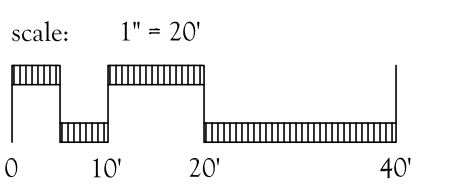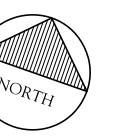

REVISIONS	DATE

PROJECT NO. XXX  
DESIGNER PROJECT NO. 149  
DRAWN: MHL CHECKED: MHL  
SCALE: AS NOTED  
ISSUE: 1/31/2018  
SHEET/TITLE

### DEPTHS AND DIMENSIONS OF PROPOSED IMPROVEMENTS

# CHARTER STREET CEMETERY PRESERVATION PROJECT

120 Washington Street, 3rd Floor  
Salem, Massachusetts  
01970

**MARTHA LYON**  
Landscape Architecture, LLC




313 Elm Street  
Northampton, MA 01060  
p: 413-586-4178  
f: 413-584-6697  
e: mhl@marthalyon.com  
www.marthalyon.com

CONSULTANT:

**SALAMONE  
&  
ASSOCIATES, P.C.**

CONSULTING ENGINEERS

116 North Plains Industrial Road  
Wallingford, Connecticut 06492  
Phone: (203) 281-6895 Fax: (203) 287-8728

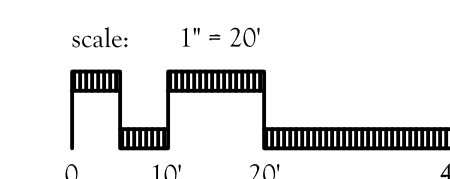

REVISIONS	DATE

PROJECT NO. XXX  
DESIGNER PROJECT NO. XXX  
DRAWN: FB CHECKED: JAS  
SCALE: AS NOTED  
ISSUE: 1/29/2018

SHEET/TITLE

SITE ELECTRICAL  
PLAN

SE-1

